


- MECHANICAL NOTES:**
- PROPOSED MAIN GAS METER LOCATION, EXACT LOCATION REFER TO ARCHITECT'S REFLECTED CEILING PLAN DWG5, (TYPICAL) APPROXIMATE GAS LOAD OF 200 CFH.
 - 508 FRESH AIR INTAKE DUCTWORK UP THRU ROOF, C/M GROSS NECK, 250x200, 150' MIN. CLEARANCE FROM OBSTACLES, APPROXIMATE GAS LOAD OF 200 CFH.
 - 508 EXHAUST DUCT UP THRU ROOF, C/M GROSS NECK, 250x200, 150' MIN. CLEARANCE FROM OBSTACLES, APPROXIMATE GAS LOAD OF 200 CFH.
 - CONSTRUCTION AIR AND EXHAUST PIPES UP THRU ROOF, C/M ROOF TERMINATION KITS.

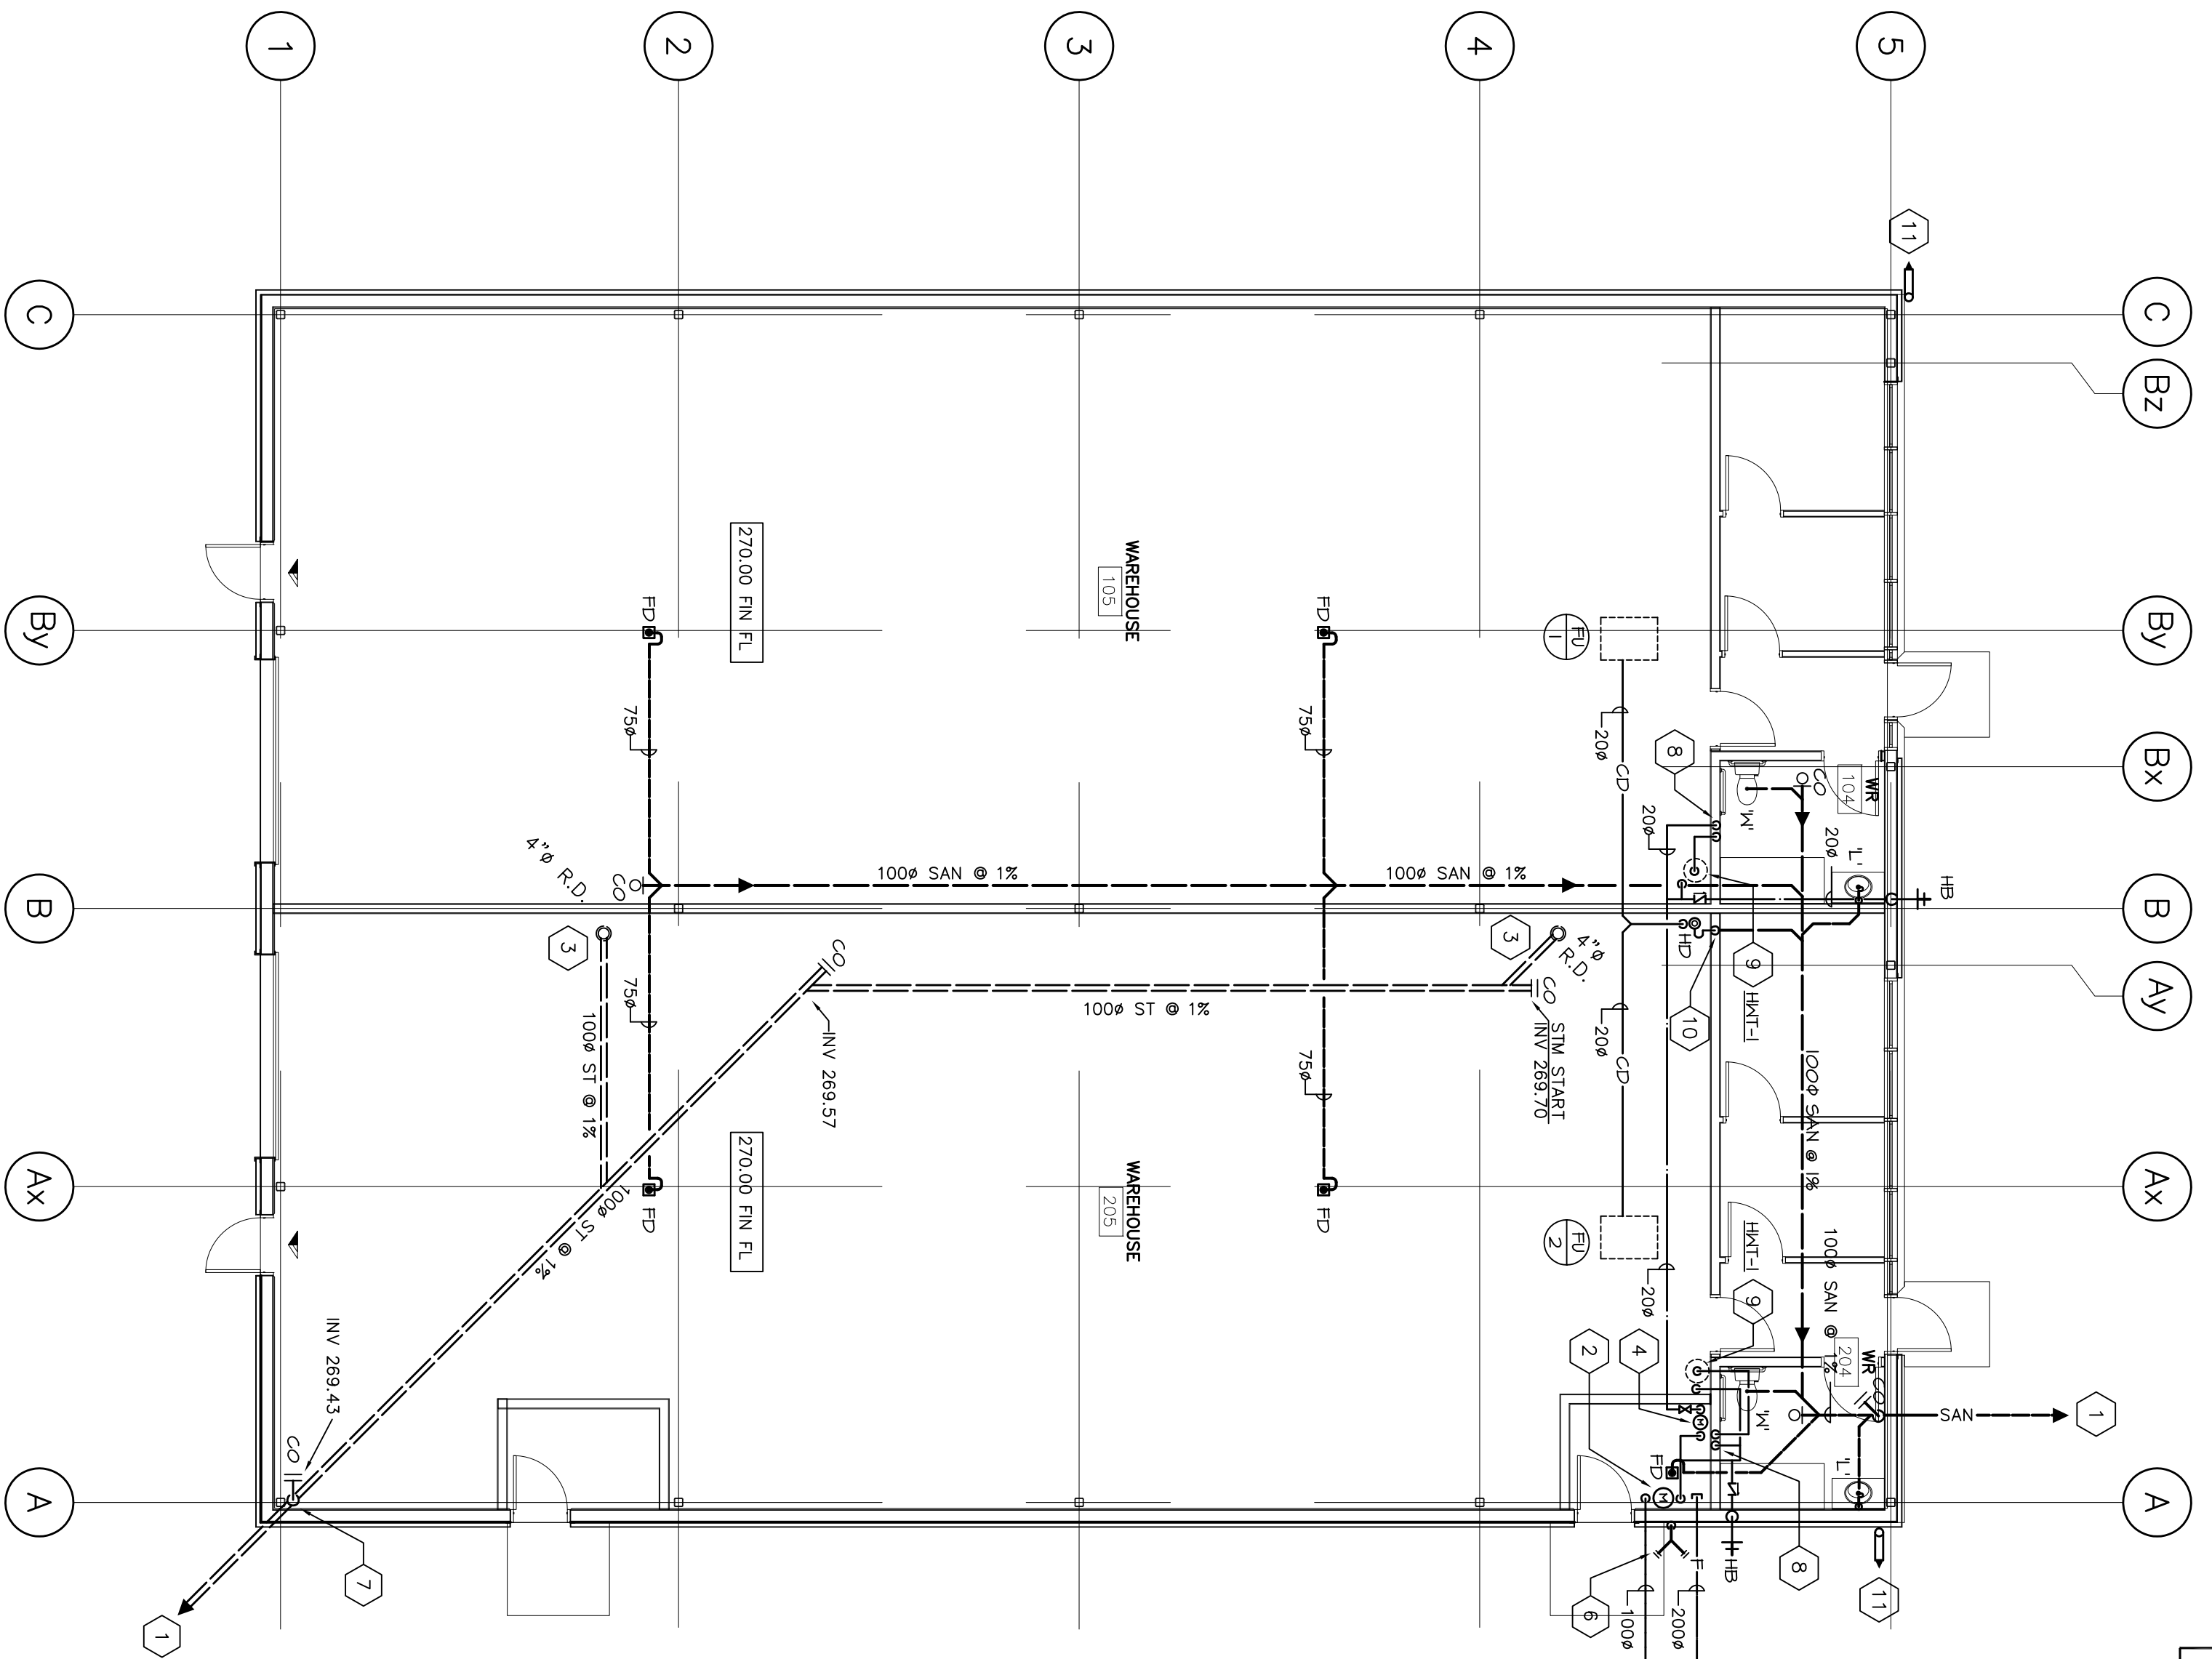

- MECHANICAL NOTES:**
- 1008 SAN @ 1% TO UNDER SIDE OF FLOOR SLAB, C/M CLEANOUT AT FLOOR.
 - 120 H AND C WATER LINES TO SERVE T1, REFER TO DWG. M-2.
 - ROOF DRAIN ABOVE, (TYPICAL)
 - 508 EXHAUST DUCT UP THRU ROOF, C/M GROSS NECK, 250x200, 150' MIN. CLEARANCE FROM OBSTACLES, APPROXIMATE GAS LOAD OF 200 CFH.
 - 508 EXHAUST DUCT UP THRU ROOF, C/M GROSS NECK, 250x200, 150' MIN. CLEARANCE FROM OBSTACLES, APPROXIMATE GAS LOAD OF 200 CFH.
 - 508 EXHAUST DUCT UP THRU ROOF, C/M GROSS NECK, 250x200, 150' MIN. CLEARANCE FROM OBSTACLES, APPROXIMATE GAS LOAD OF 200 CFH.

NOTE:

- ALL FLOOR DRAIN & HD DRAINS TO HAVE TRAP PROBER.
- ALL HOT AND COLD WATER PIPING TO BE INSULATED.
- EXACT ELEVATIONS, INVERTS AND SLOPES OF SANITARY AND STORM LINES TO BE DETERMINED ON SITE BY LOCAL CONTRACTORS. EXACT TERMINATION OF SERVICES WITH LOCATION SHOWN ON DRAWING.

| NO. | DESCRIPTION | DATE | BY |
|-----|-------------------|----------|----|
| 1 | ISSUED FOR PERMIT | 29/01/16 | JK |
| 2 | ISSUED FOR TENDER | 04/01/15 | JK |

MARK VOID ALL PRINTS DATED PREVIOUS TO FINAL DATE ABOVE

REVISIONS

CONTRACTOR MUST CHECK AND VERIFY ALL DIMENSIONS TO THE ENGINEER'S BEFORE PROCEEDING WITH WORK AND THIS DRAWING IS THE PROPERTY OF THE ENGINEER AND MUST BE RETURNED ON COMPLETION OF THE WORK. DRAWINGS ARE NOT TO BE SCALED.

J. D. Hubbert & Associates
 209 EVANS AVENUE, UNIT NO. 11
 ETOBICOKE, ONTARIO, CANADA
 TEL: (416) 251-3440 FAX: (416) 251-9168
 E-MAIL: jdh@eng.on.on.ca

REGISTERED PROFESSIONAL ENGINEER
 J. D. Hubbert
 Ontario Professional Engineer
 License No. 1105

JOCHRI INVESTMENT LTD.
 190 INDUSTRIAL PARKWAY SOUTH
 AURORA, ONTARIO

PROJECT TITLE: **GROUND FLOOR PLANS MECHANICAL**

DESIGNED BY: JK
 DRAWN BY: JK
 DATE: JULY 2015

SCALE: 1:100
 PROJECT NUMBER: **5-4670**
 DRAWING NUMBER: **M-1**
 Insert