


MECHANICAL NOTES:


1 75# RUL DN. AND SPLASH WATER ON GRADE.

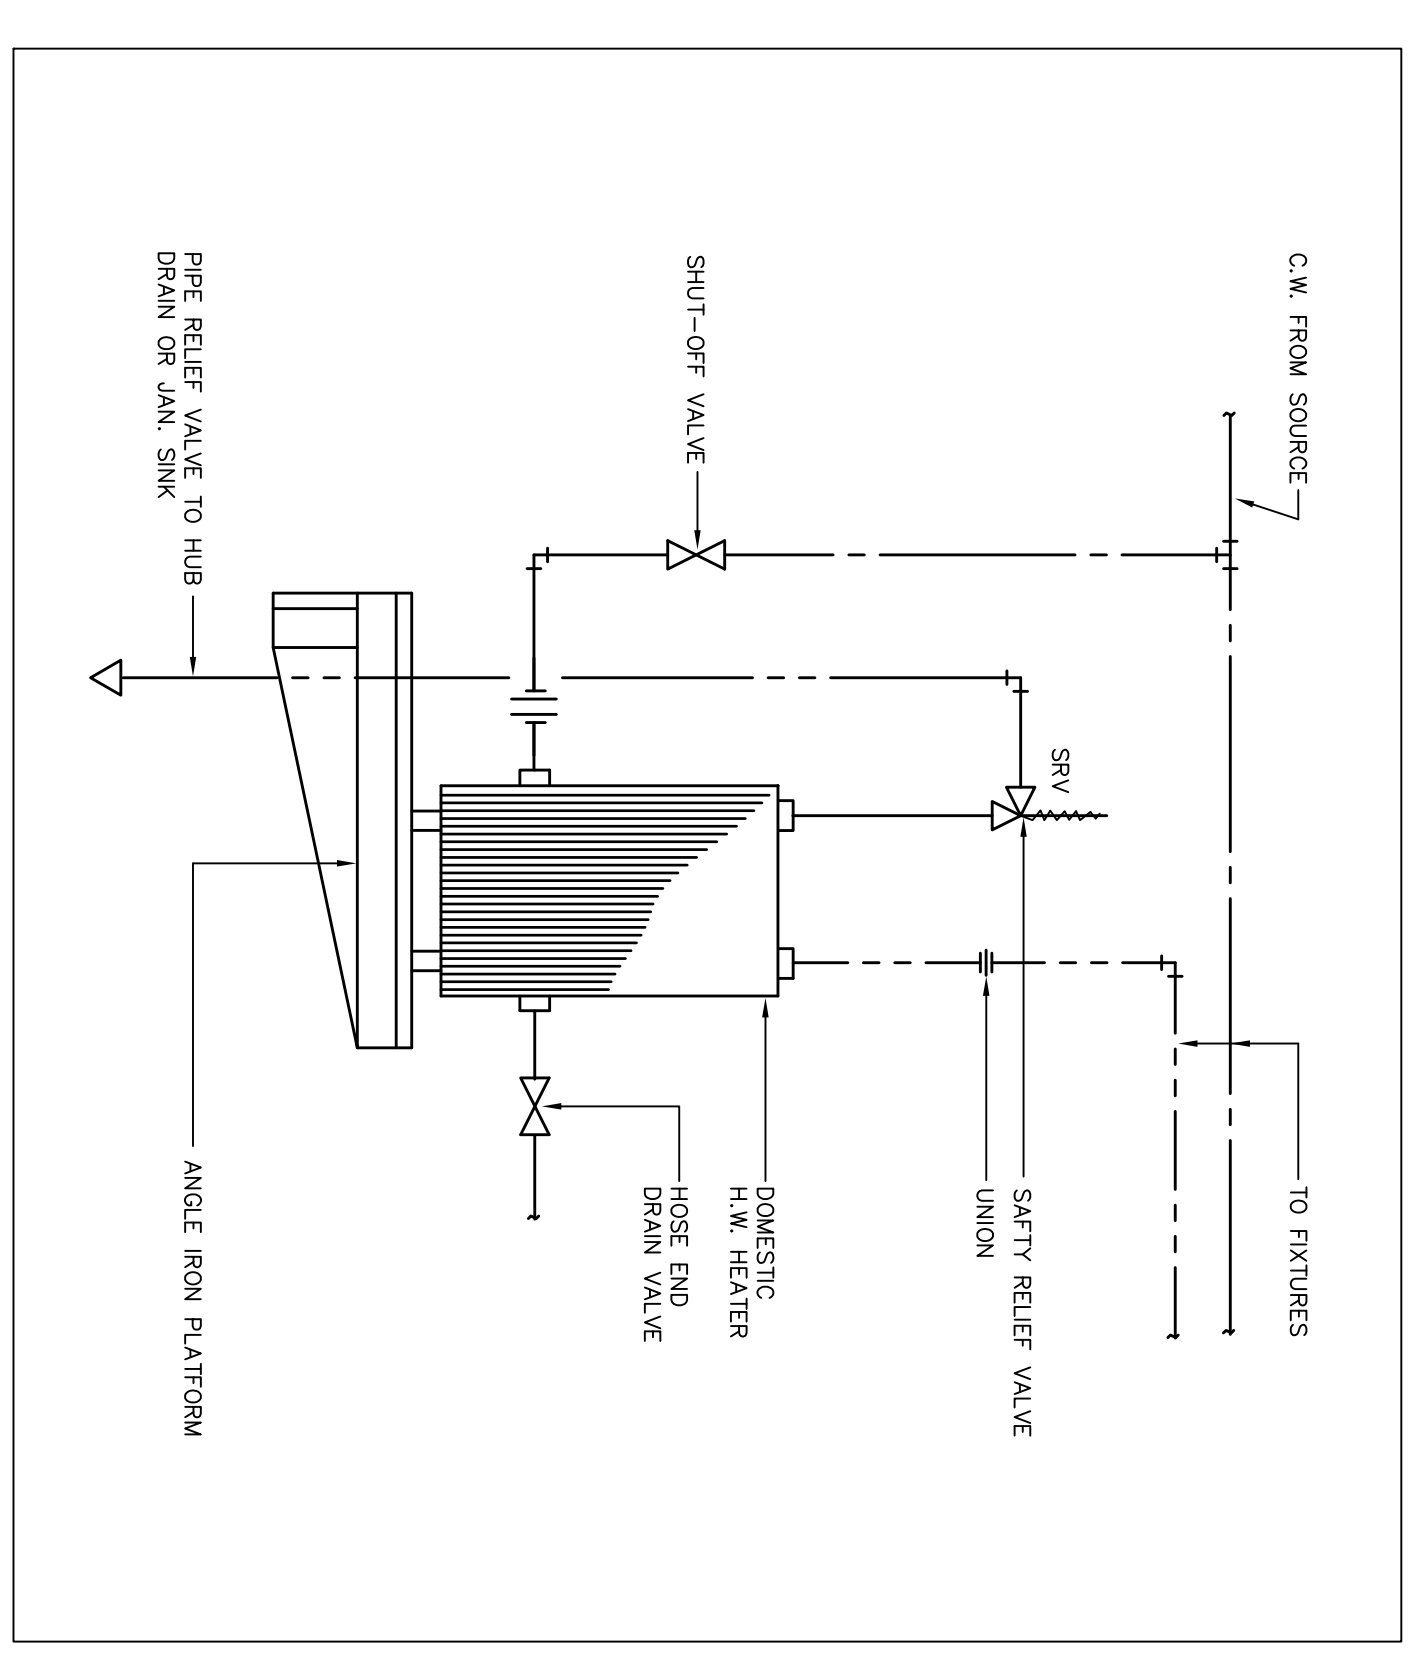

DOM. H.W.TANK CEILING MOUNTED
M-1
N.T.S.

- WATER METER NOTES**
- 400 MM DOMESTIC WATER METER BY CROMPTON (STANDARD) AS PER SPECIFICATION
 - GATE VALVE
 - BRASS VALVE
 - BRASS VALVE SEALED BY CITY OF ABERDOLWEN (TYP)
 - COPING UNION (TYP)
 - PRESSURE GAUGE

- NOTES:**
- THE DIAMETER OF THE BY-PASS LINE SHALL MATCH THE DIAMETER OF THE MAIN LINE.
 - ALL MATERIAL SHALL BE SUPPLIED BY THE CONTRACTOR, EXCEPT WATER METER AND VALVES WHICH SHALL BE SUPPLIED BY THE CITY OF ABERDOLWEN.
 - SUBSTITUTED WITH BUTTERFLY VALVES, FULL FLOW IS NECESSARY FOR PROPER METER REGISTRATION.
 - VALVE TO BE INSPECTED AND SEALED BY THE CITY OF ABERDOLWEN.
 - STRAINER MAY BE REQUIRED AT CITY OF ABERDOLWEN DISCRETION.
 - ALL DIMENSIONS ARE IN MILLIMETERS UNLESS OTHERWISE NOTED.

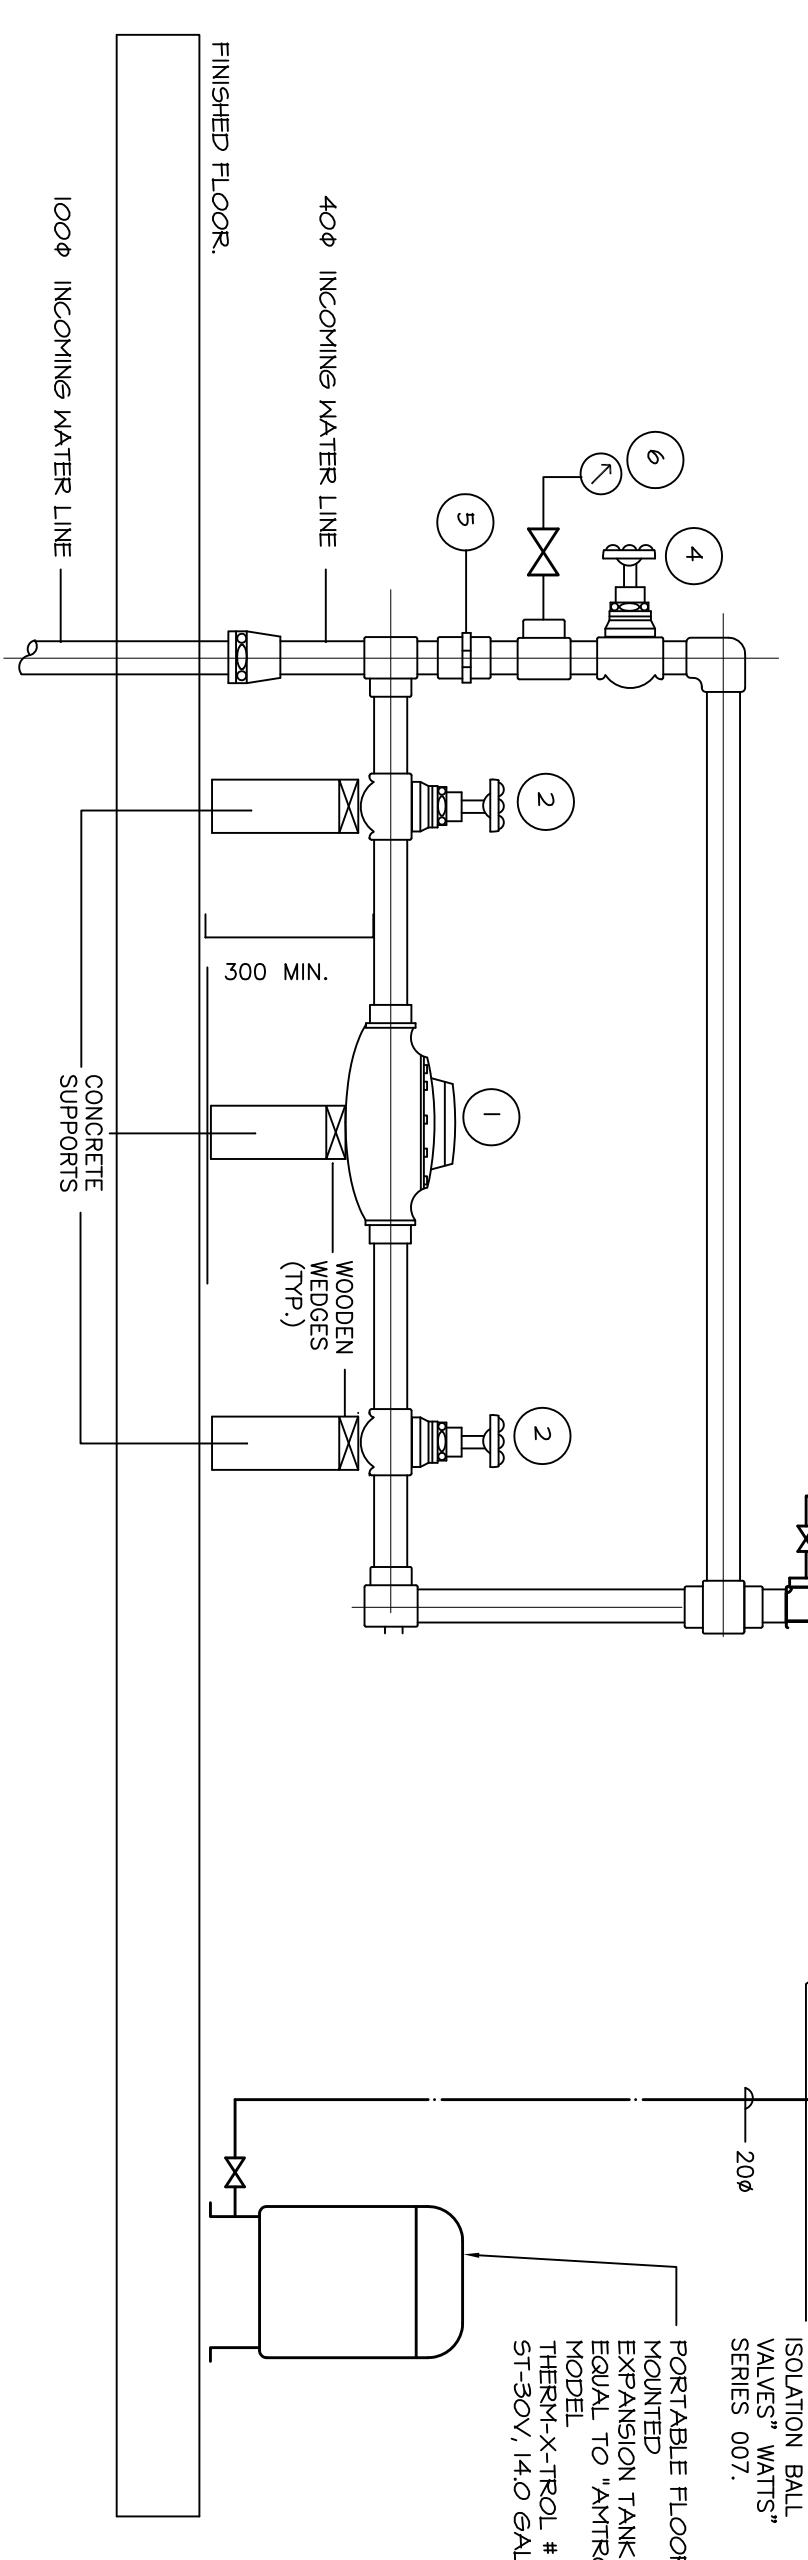


DOMESTIC WATER METER SCHEMATIC
N.T.S.

NO.	DESCRIPTION	BY
1	ISSUED FOR PERMIT	JK
2	ISSUED FOR TENDER	JK

REVISIONS

CONTRACTOR MUST CHECK AND VERIFY ALL DIMENSIONS TO THE DRAWING BEFORE PROCEEDING WITH WORK AND THIS DRAWING IS THE PROPERTY OF THE ENGINEER AND MUST BE RETURNED ON COMPLETION OF THE WORK. DRAWINGS ARE NOT TO BE SCALED.

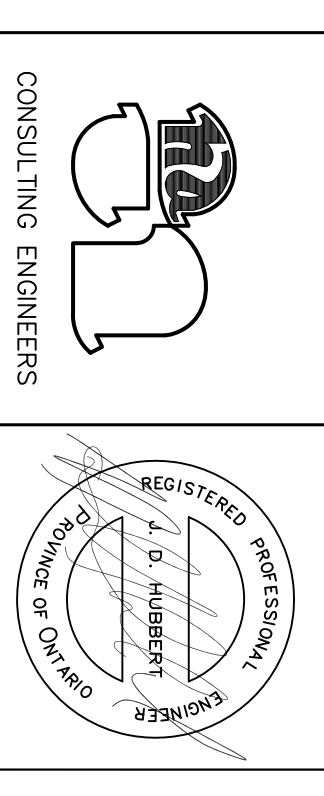

J. D. Hubbert & Associates
200 EVANS AVENUE, UNIT NO. 11
ETOBICOKE, ONTARIO, CANADA
TEL: (416) 251-3440 FAX: (416) 251-9166
E. MAIL: jdheng@ohb.com

PROJECT TITLE
ROOF PLAN
MECHANICAL

CLIENT
JOCHRI INVESTMENT LTD.

PROJECT ADDRESS
190 INDUSTRIAL PARKWAY SOUTH
AURORA, ONTARIO

DATE
JULY 2015

PROJECT NUMBER
5-4670

DRAWING NUMBER
M-2 Insert